
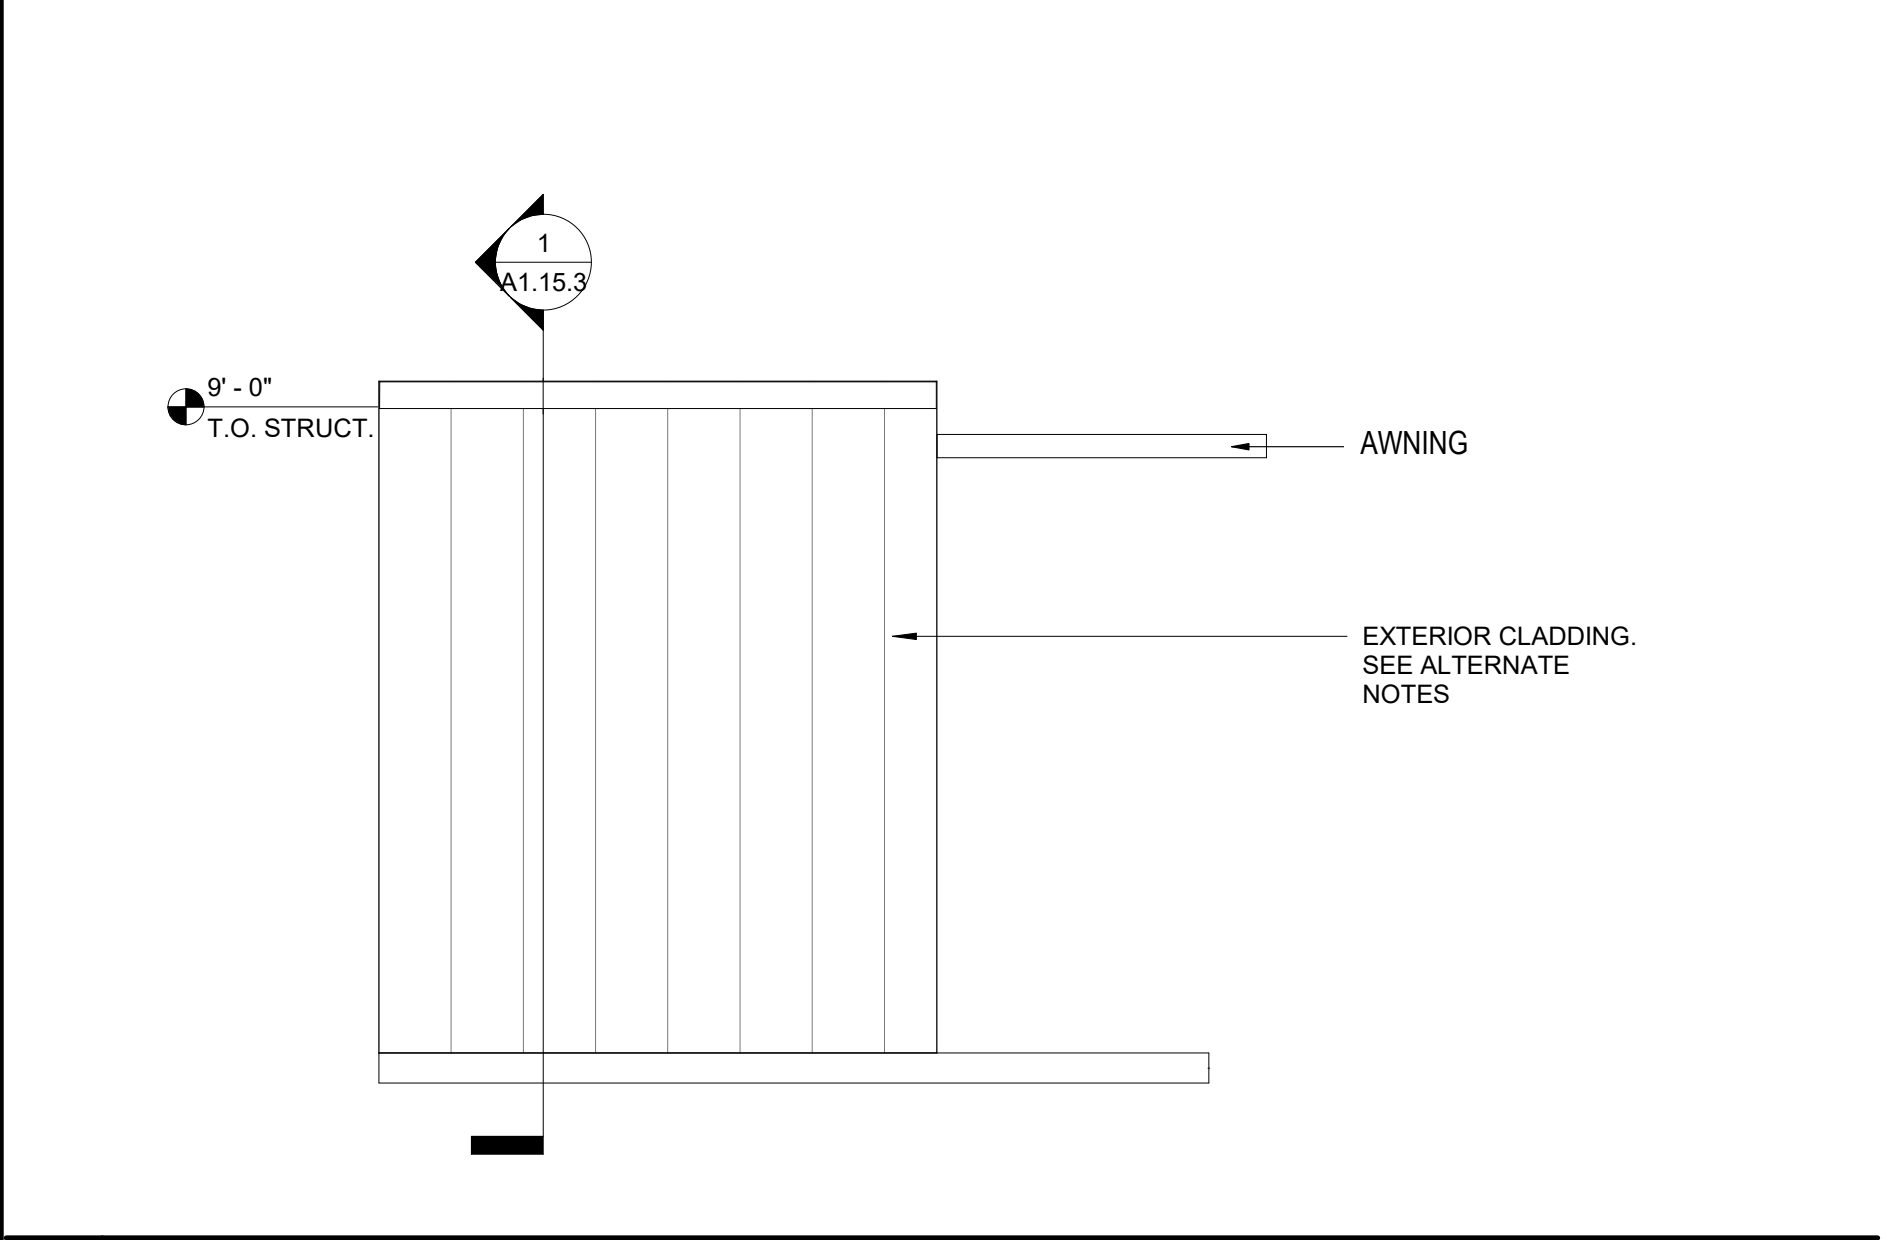


KEY	ITEM	MANUFACTURER	DESCRIPTION	REMARKS
PT-1	GENERAL PAINT	BENJAMIN MOORE	WHITE DOVE	LOW VOC, EGGSHELL @ WALLS, SEMI-GLOSS @ BASE, FLAT @ CEILING
PT-2	ACCENT PAINT	BENJAMIN MOORE	CHEATING HEART	LOW VOC, EGGSHELL @ WALLS, SEMI-GLOSS @ BASE, FLAT @ CEILING
PT-3	ACCENT PAINT	BENJAMIN MOORE	AMHERST GRAY	LOW VOC, EGGSHELL @ WALLS, SEMI-GLOSS @ BASE
PT-4	ACCENT PAINT	BENJAMIN MOORE	ROCKPORT GRAY	LOW VOC, EGGSHELL @ WALLS, SEMI-GLOSS @ BASE
B-1	WOOD WALL BASE		PAINTED PT-1 3.5" STRAIGHT BASE.	
B-2	WOOD WALL BASE		PAINTED PT-2 3.5" STRAIGHT BASE.	
WD-1	WOOD FLOOR	FLOOR & DECOR	LIFESCAPES MOCHA HICKORY HAND SCRAPPED ENGINEERED HARDWOOD	
WD-2	WOOD FLOOR	FLOOR & DECOR	LIFESCAPES DAVENTRY HICKORY HAND SCRAPPED ENGINEERED HARDWOOD	
WD-3	WOOD FLOOR	FLOOR & DECOR	LIFESCAPES LIGHT BROWN HICKORY DISTRESSED LOCKING ENGINEERED HARDWOOD	
WD-4	WOOD FLOOR	FLOOR & DECOR	AMERICAN SPIRIT KENDREE HICKORY WIRE-BRUSHED ENGINEERED HARDWOOD	


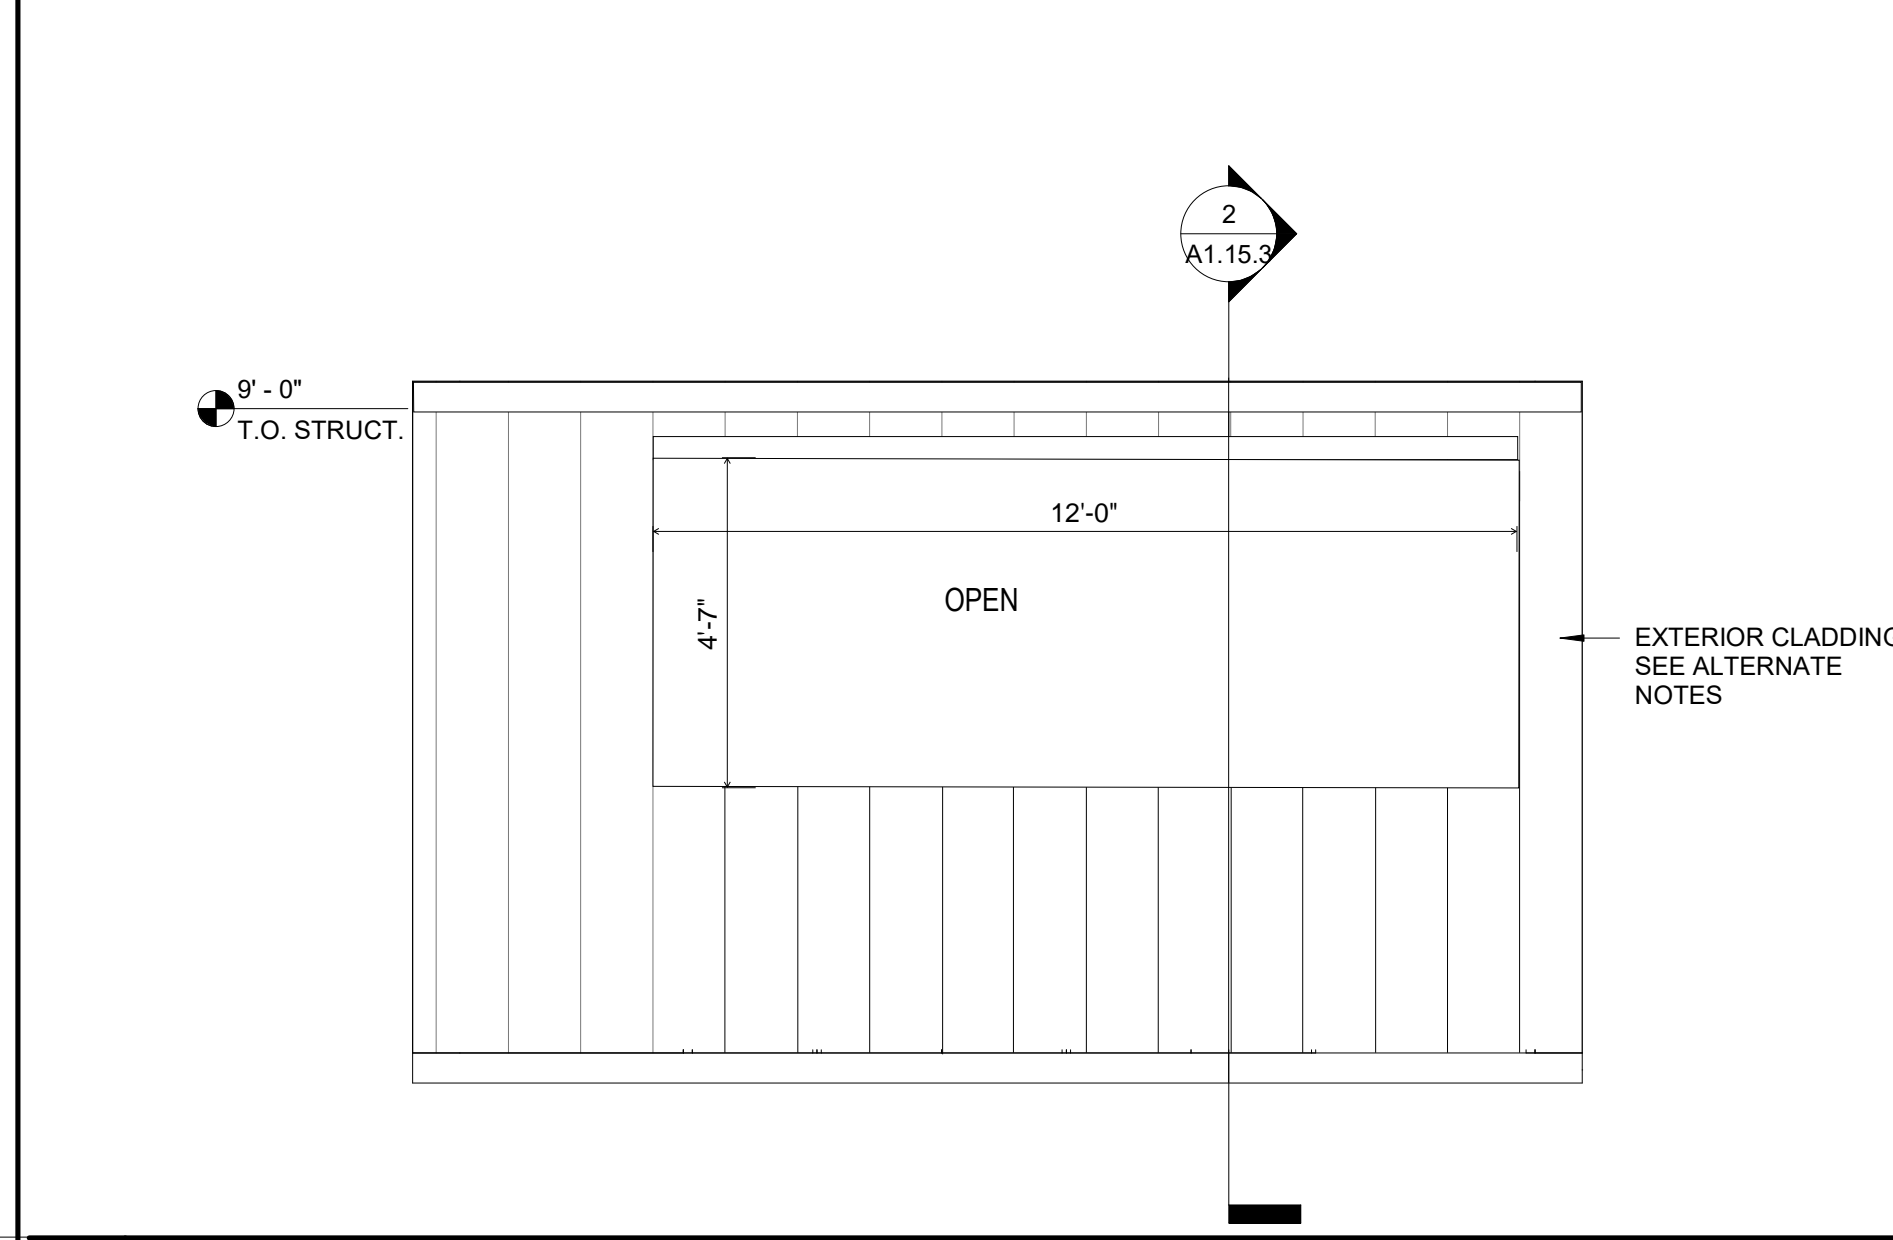


9 FINIISH SCHEDULE

6 EXTERIOR BUILDING ELEVATION - SOUTH 3/8" = 1'-0"

3 EXTERIOR BUILDING ELEVATION - WEST 3/8" = 1'-0"

1. FINISHES AS NOTED, U.O.N. IN THIS SECTION.
 2. PROVIDE ALTERNATE PRICING FOR THE FOLLOWING:
 A. SCHEME 2:
 a. PROVIDE WD-2 FLOOR FINISH.
 B. SCHEME 3:
 a. PROVIDE ACCENT PAINT PT-3 AND B-1 ON NORTH INTERIOR WALL AND PT-1 AND B-1 ON ALL OTHER WALLS.
 b. PROVIDE WD-3 FLOOR FINISH.
 C. SCHEME 4:
 a. PROVIDE ACCENT PAINT PT-4 AND B-1 ON NORTH INTERIOR WALL AND PT-1 AND B-1 ON ALL OTHER WALLS.
 b. PROVIDE WD-4 FLOOR FINISH.

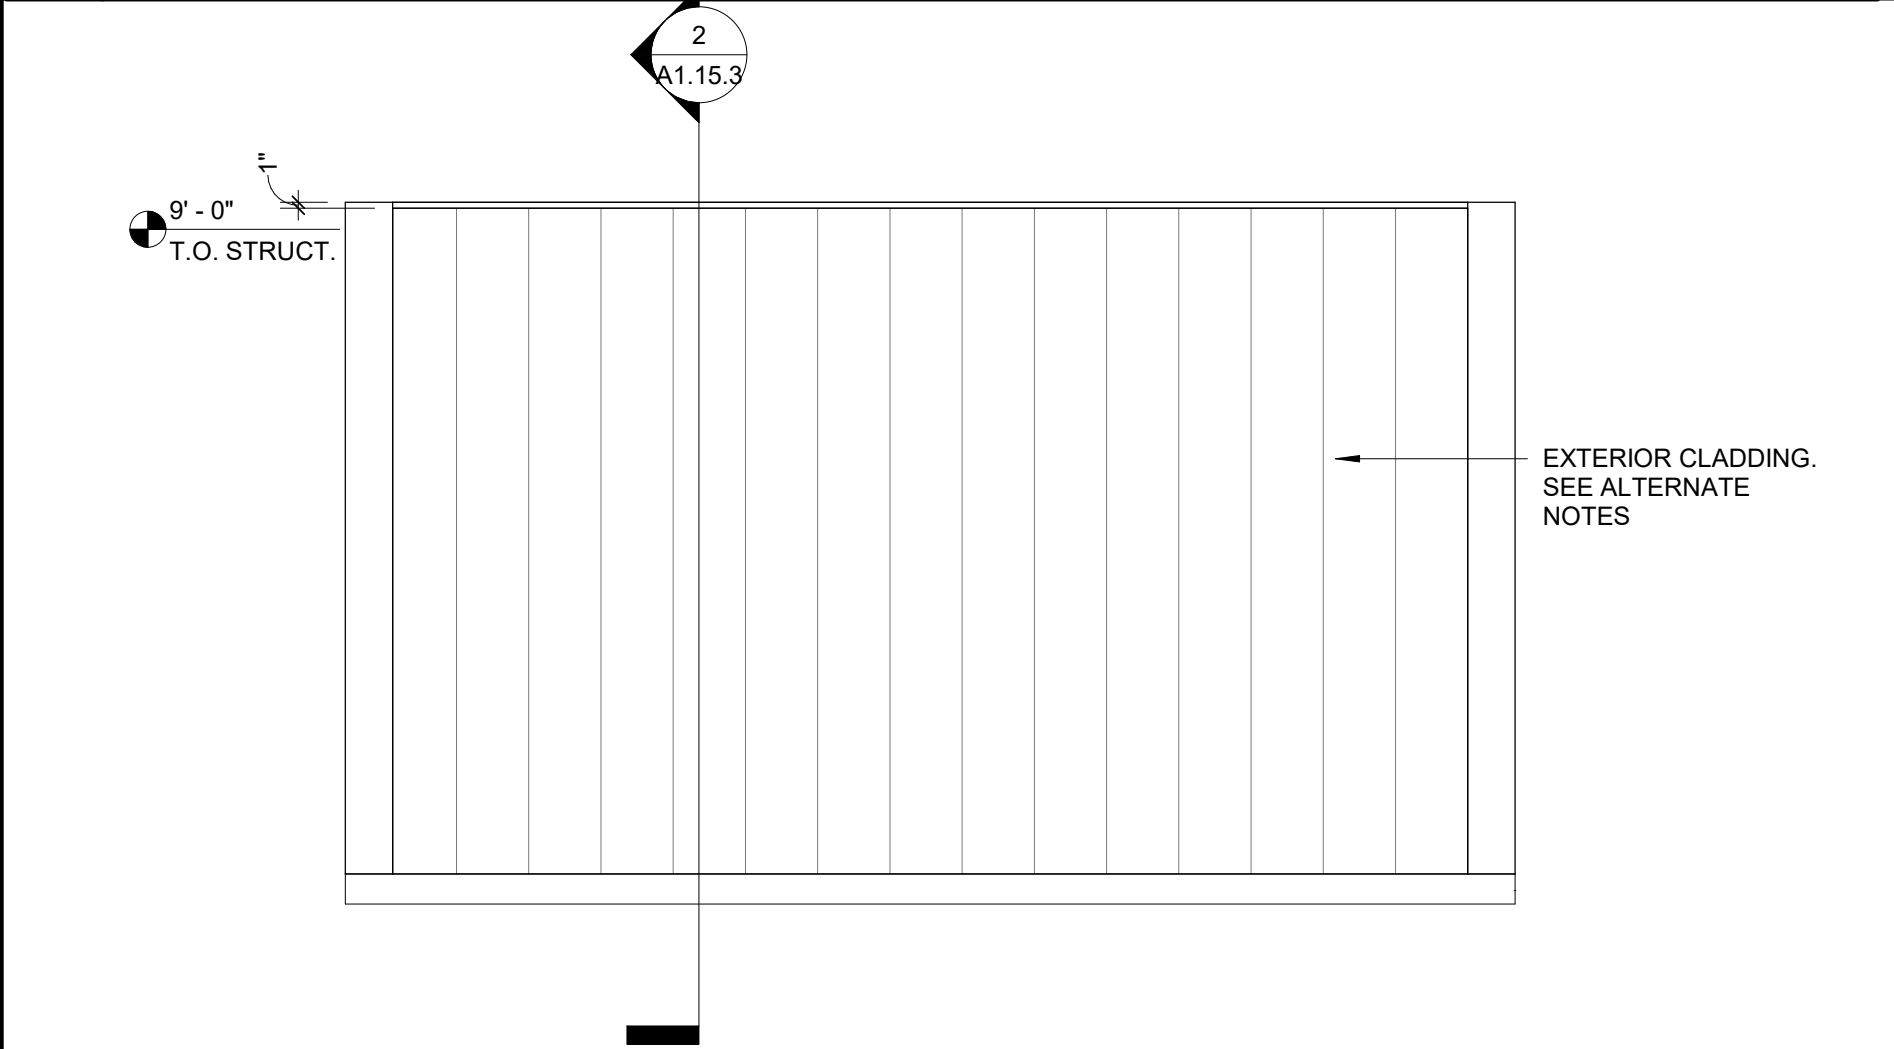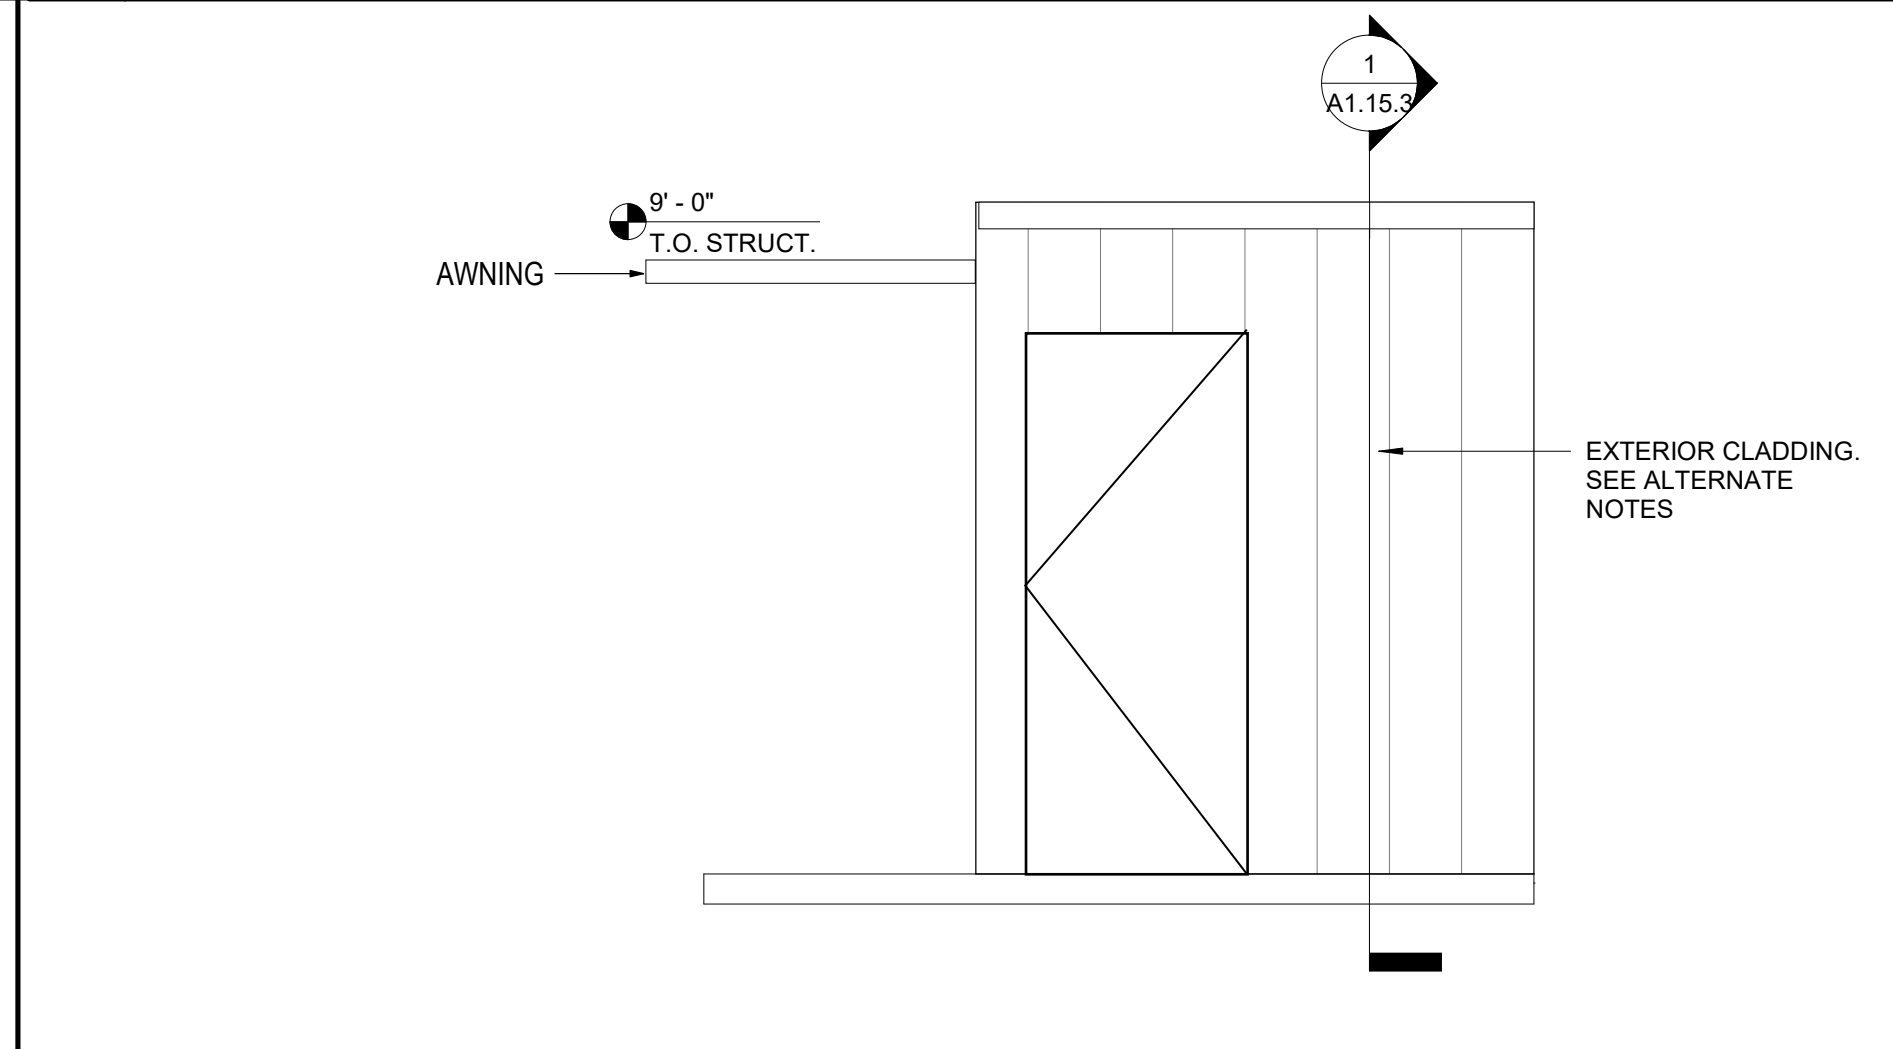


8 ALTERNATIVE FINISH NOTES

5 EXTERIOR BUILDING ELEVATION - EAST 3/8" = 1'-0"

2 EXTERIOR BUILDING ELEVATION - NORTH 3/8" = 1'-0"

1. REFER TO SHEET A4.01 FOR WALL TYPE LEGEND.
 2. PROVIDE ALTERNATE PRICING FOR THE FOLLOWING:
 A. SCHEME 3:
 a. EXTERIOR CLADDING MATERIAL TO BE HORIZONTAL GREY WOOD SIDING IN LIEU OF PAINTED CORRUGATED METAL. MATCH ARCHITECT'S SAMPLE. REFER TO WALL SECTION DETAILS FOR MORE INFO.
 B. SCHEME 4:
 a. EXTERIOR CLADDING MATERIAL TO BE VERTICAL NATURAL WOOD SIDING IN LIEU OF PAINTED CORRUGATED METAL. MATCH ARCHITECT'S SAMPLE. REFER TO WALL SECTION DETAILS FOR MORE INFO.

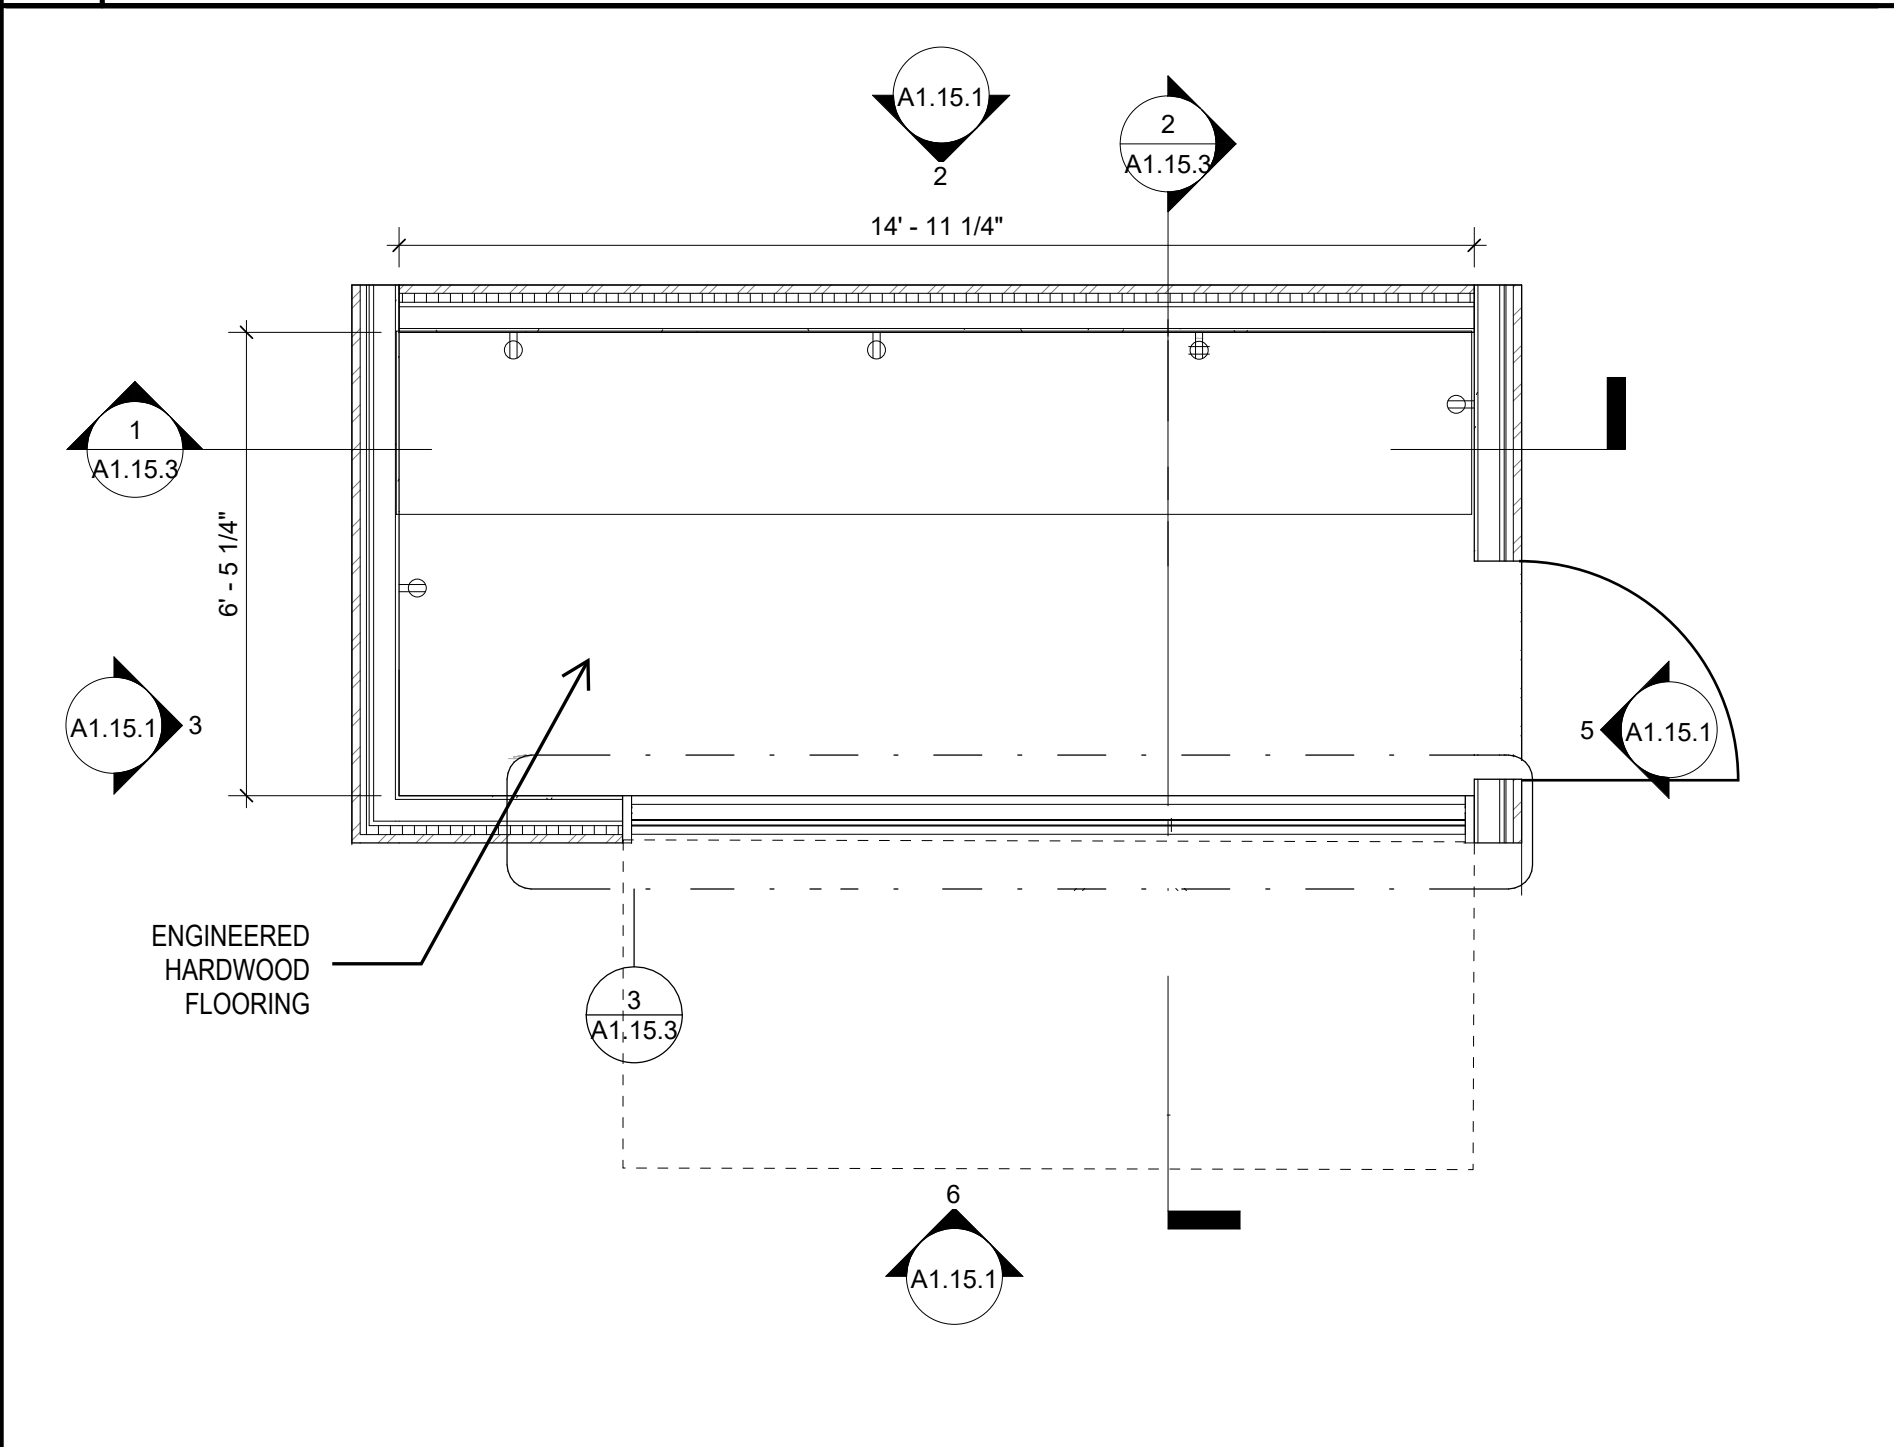

7 CONSTRUCTION SHEET NOTES

1 CONSTRUCTION & POWER PLAN - 1.5D 3/8" = 1'-0"

1 CONSTRUCTION & POWER PLAN - 1.5D 3/8" = 1'-0"

ASD | SKY

55 Ivan Allen Jr. Blvd.
 Suite 100
 Atlanta, GA 30308
 T 404.688.3318
 F 404.688.2255
 www.asdsky.com



STANDARD FINISH TAG. REFER TO FINISH SCHEDULE.
 MULTIPLE FINISHES OCCUR AT SOME LOCATIONS. SEE FINISH PLAN AND ELEVATIONS FOR DETAILS.

This drawing is the property of Associated Space Design, Inc. and is not to be reproduced or copied in whole or part. It is not to be used on any other project and is to be returned upon request. Scales as stated herein are for reference only as normal reproduction processes may alter the accuracy of original drawings.
 Associated Space Design, Inc. 2015

NO.	DATE	REVISIONS

NO. DATE REMARKS

DRAWING TITLE:
CONST. PLAN, FINISH PLAN, & ELEVATIONS - OPTION 1.5D

PROJECT NO.: _____ ISSUE DATE: 03/01/21
 DRAWN BY: Author CHECKED BY: Checker

SHEET NUMBER:
A1.15.1

5/20/2021 10:03:51 AM

NOTE: OFFICE POD ENTRANCE DOOR(S) TO BE

- FOLDING GLAZED WALL SYSTEM, BASIS OF DESIGN: NANAWALL SL60, ALUMINUM-FRAMED, THERMALLY BROKEN, FLOOR MOUNTED
- SLIDING PANELS, BASIS OF DESIGN: NANAWALL HSW60, ALUMINUM-FRAMED, THERMALLY BROKEN

OR



- DOUBLE DOORS W/SIDELITES, BASIS OF DESIGN: PELLA ARCHITECT SERIES - CONTEMPORARY HINGED PATIO DOORS

NOTE: OFFICE POD ROOF TO BE

- STANDING SEAM METAL, BASIS OF DESIGN: PAC-CLAD SNAP-CLAD PANEL ROOFING SYSTEM
- ROOF SHINGLES, BASIS OF DESIGN: GAF ROYAL SOVEREIGN WHITE ALGAE RESISTANT 3-TAB

OR

- TPO MEMBRANE, BASIS OF DESIGN: GAF EVERGUARD TPO 80 MIL. MEMBRANE

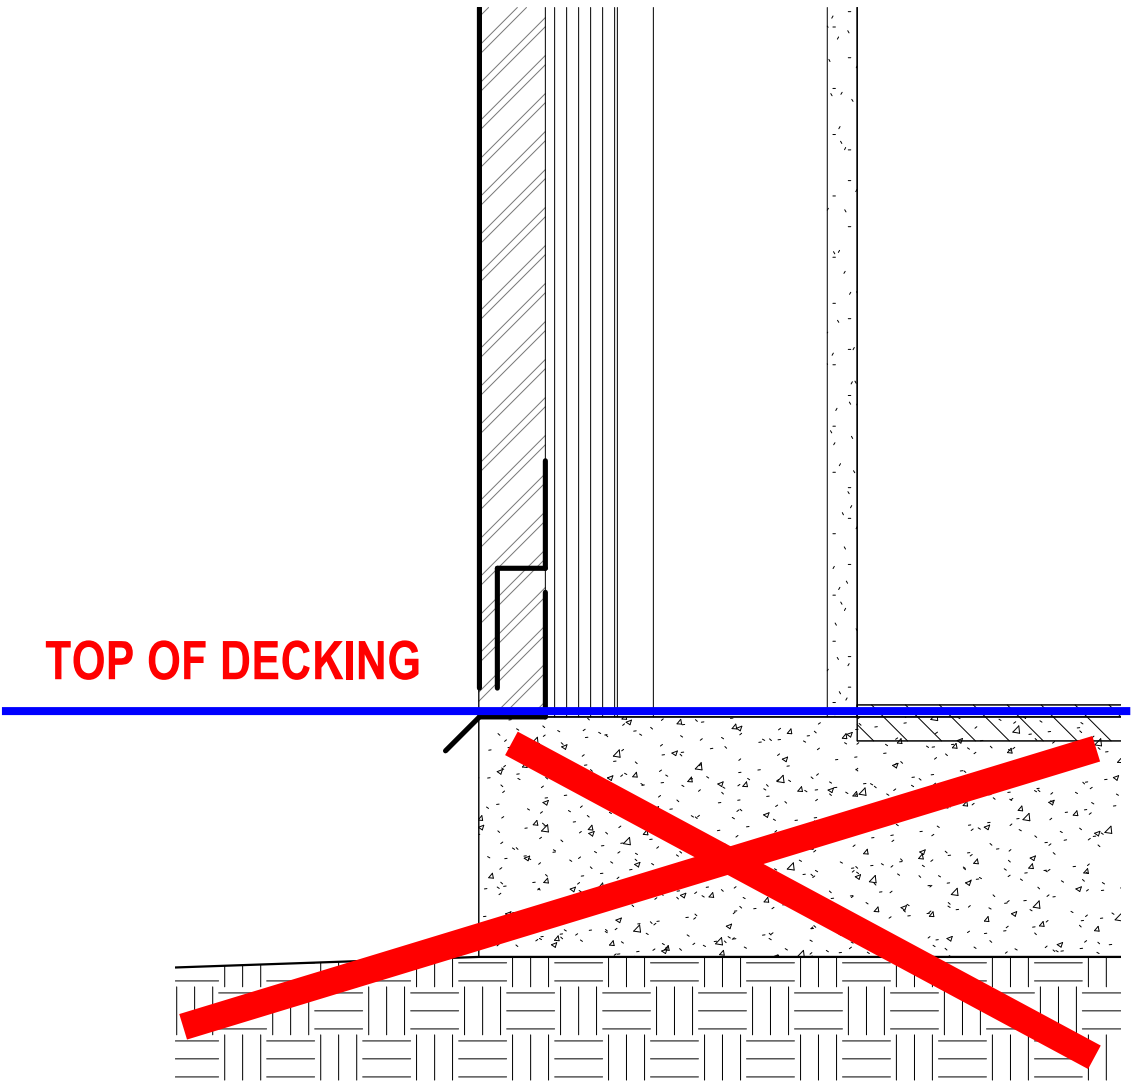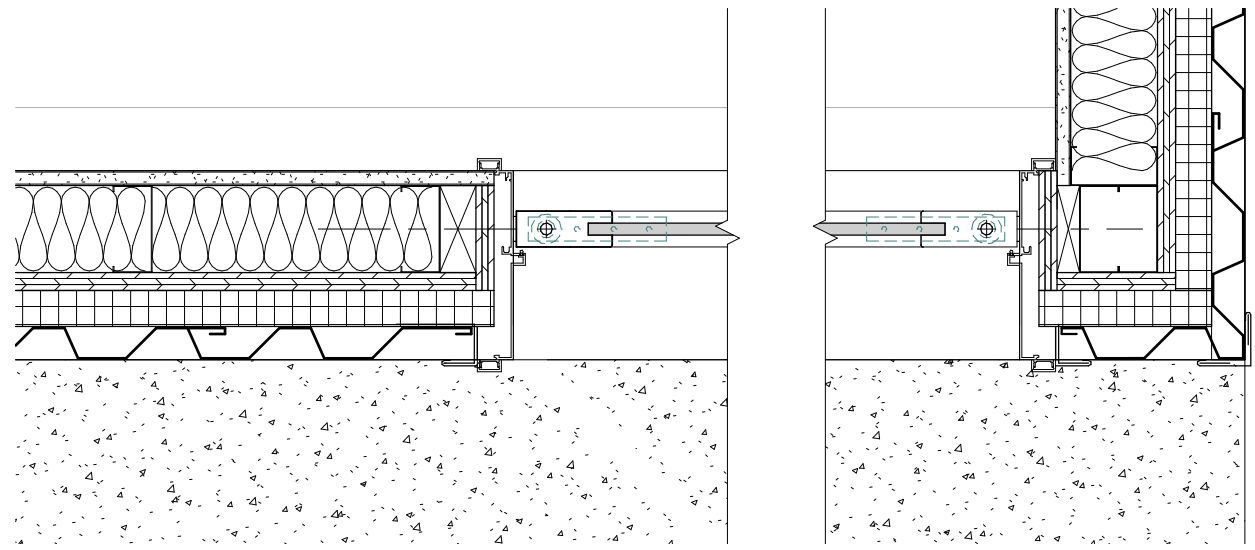

3 PLAN DETAIL - FD JAMB 1 1/2" = 1'-0"

4 SECTION DETAIL - WALL BASE 3" = 1'-0"

This drawing is the property of Associated Space Design, Inc. and is not to be reproduced or copied in whole or part. It is not to be used on any other project and is to be returned upon request. Scales as stated herein are for reference only as normal reproduction processes may alter the accuracy of original drawings. Associated Space Design, Inc. 2015




NO.	DATE	REMARKS

REVISIONS:

SECTION 1.5D

PROJECT NO.:
 ISSUE DATE: 03/08/21
 DRAWN BY: Author
 CHECKED BY: Checker
 SHEET NUMBER:

A1.15.3

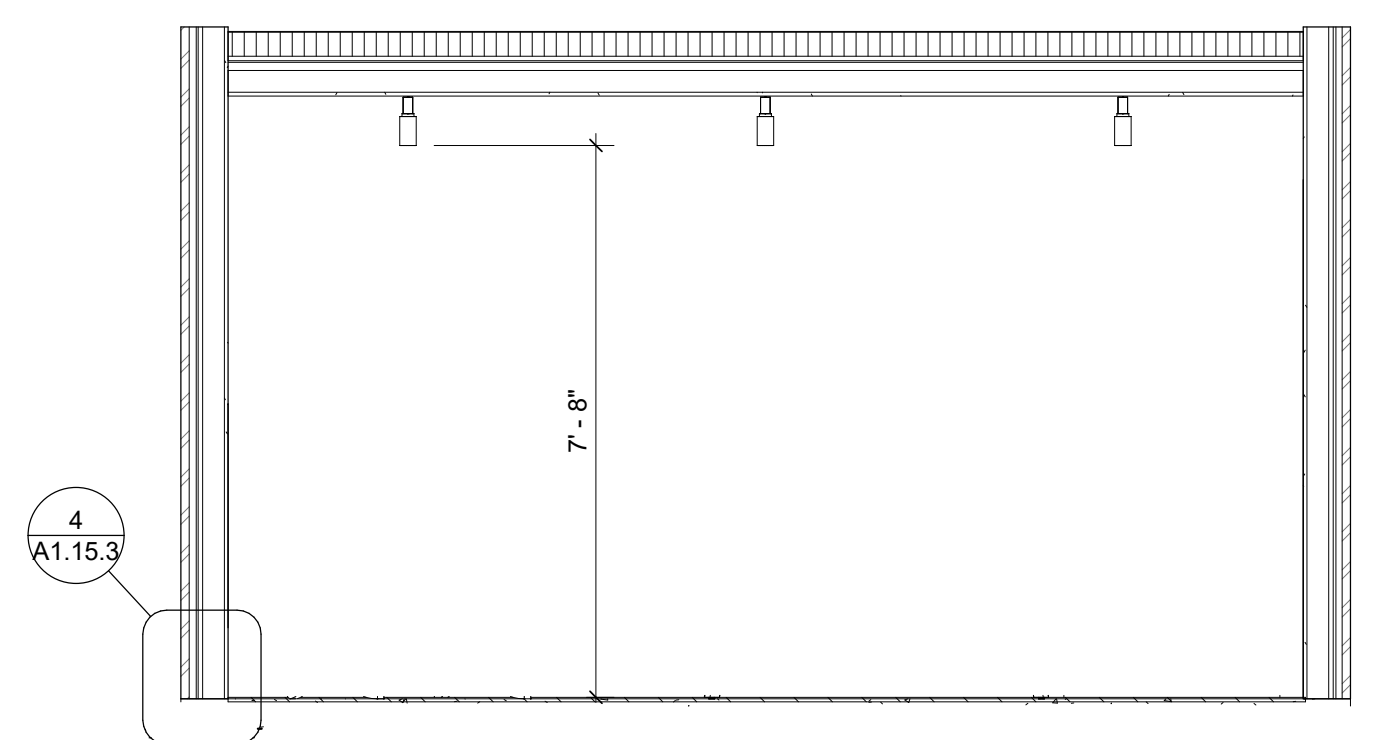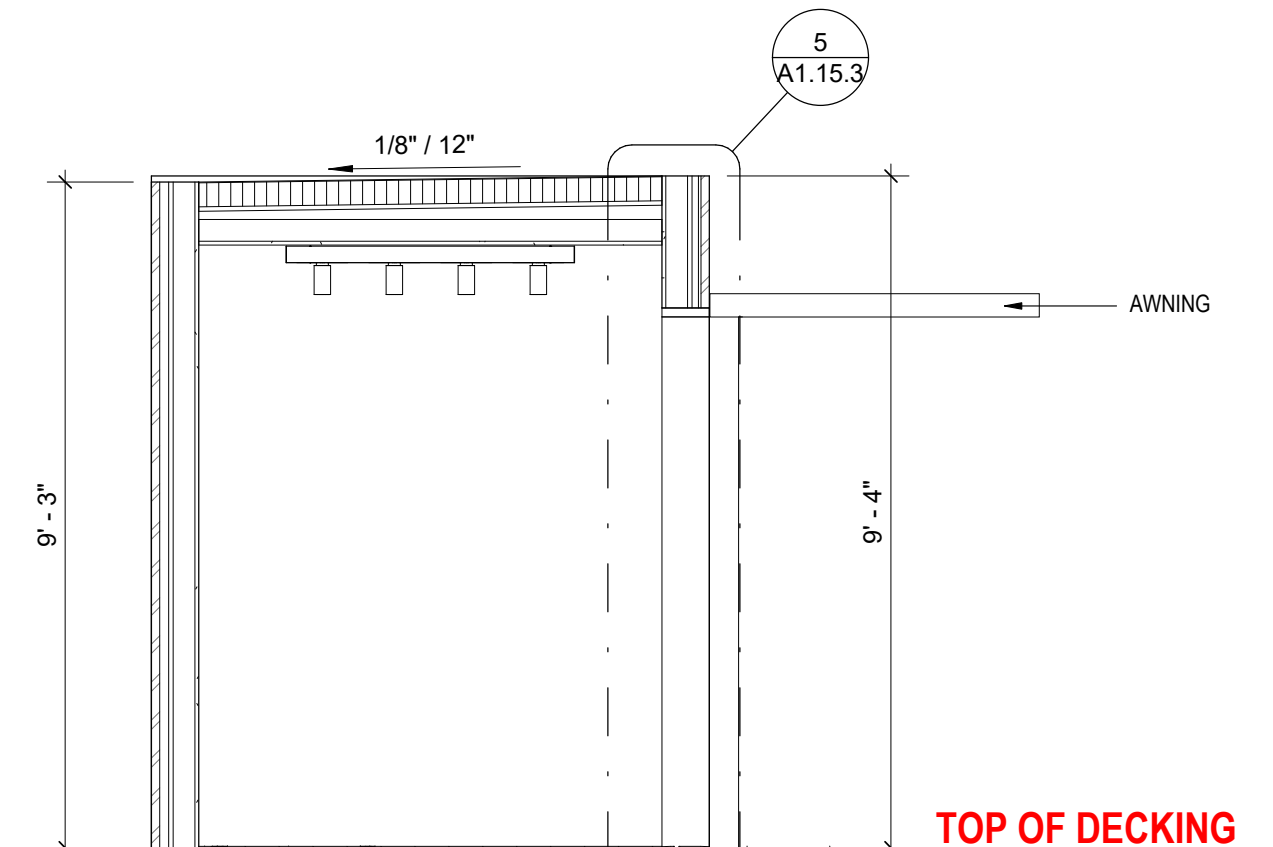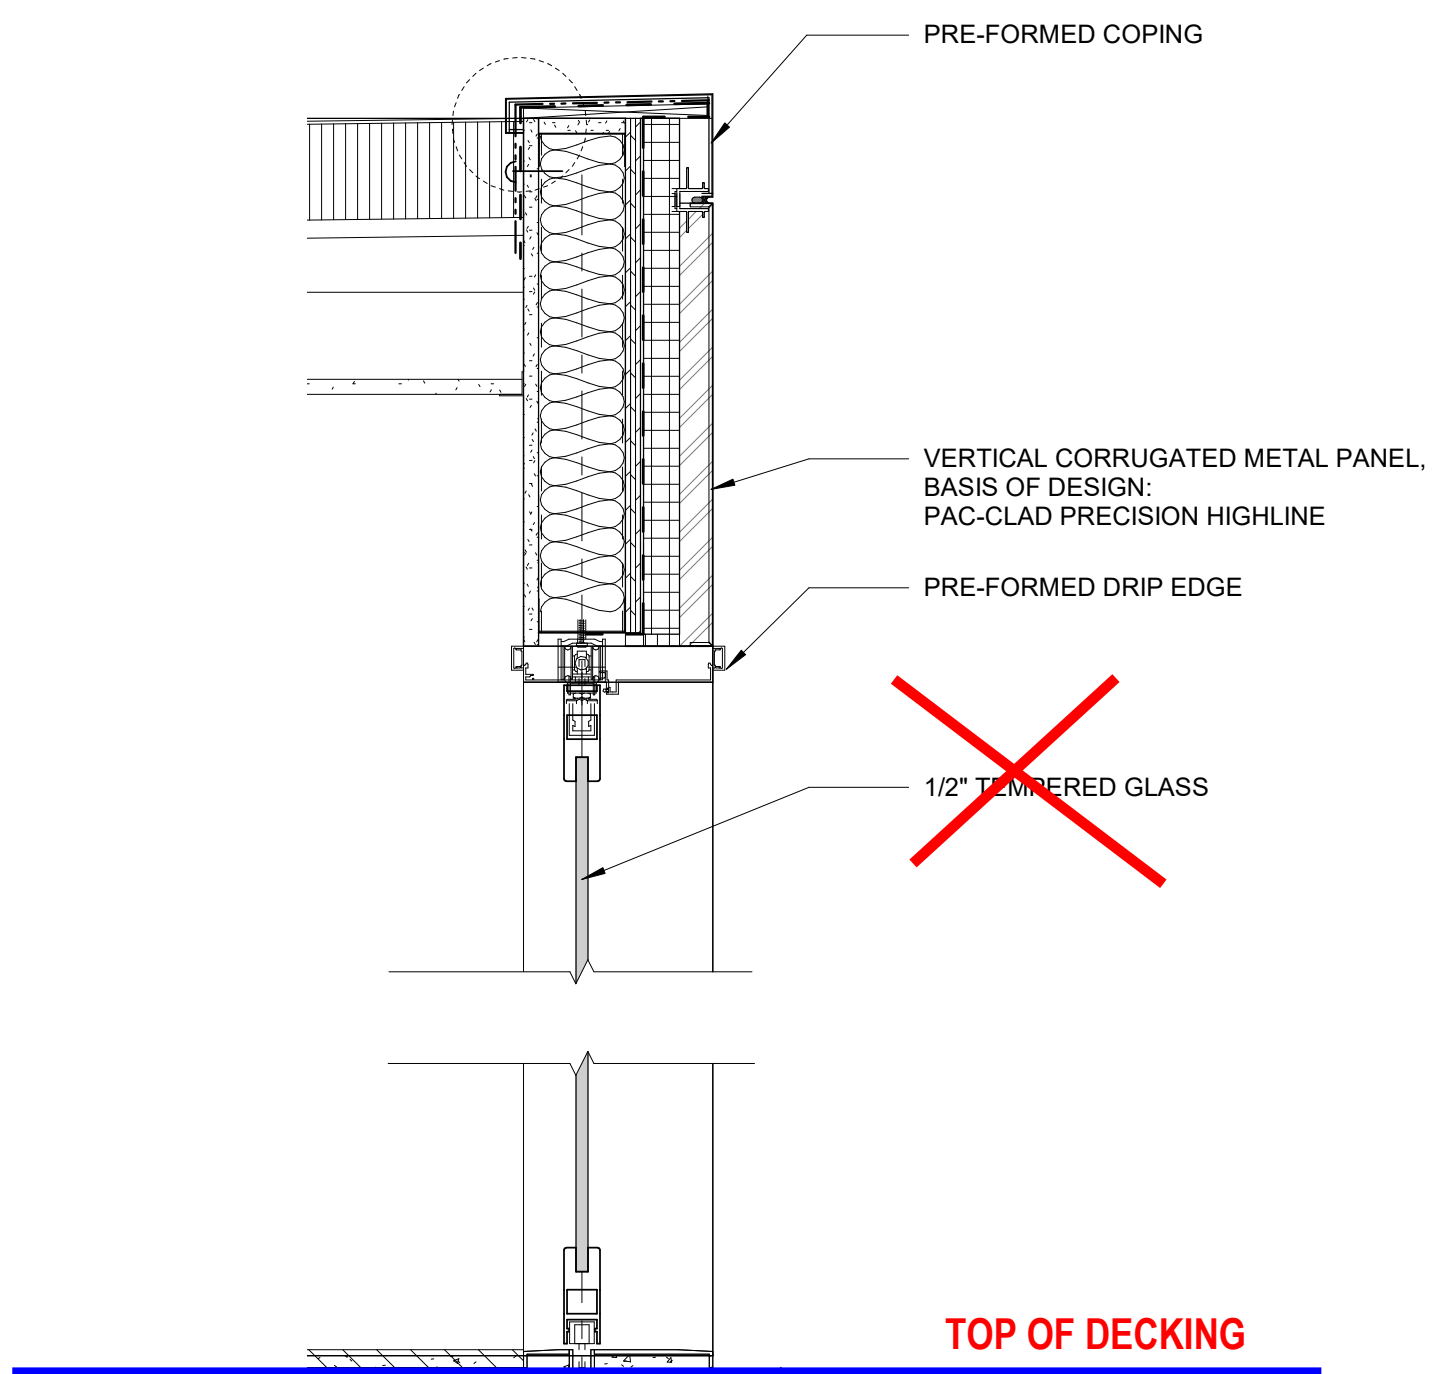


5 SECTION DETAIL - ROOF/FD HEAD & SILL 1 1/2" = 1'-0"


2 SECTION 2 3/8" = 1'-0"

1 SECTION 1 3/8" = 1'-0"

5/20/2021 10:03:51 AM

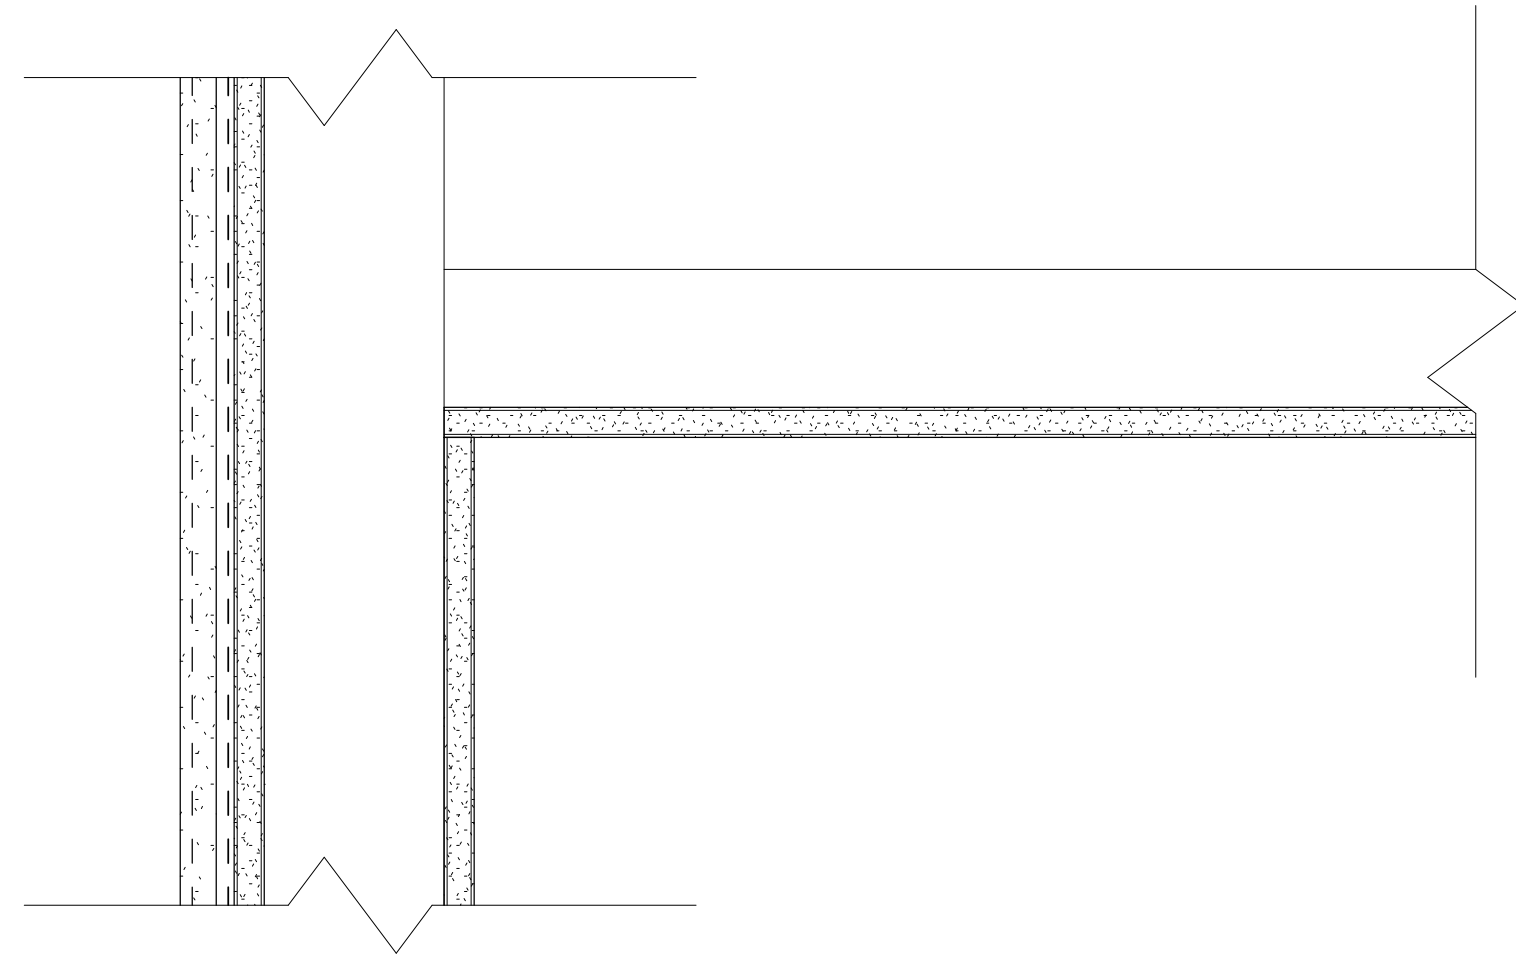


6 GYP CEILING DETAIL 3" = 1'-0"

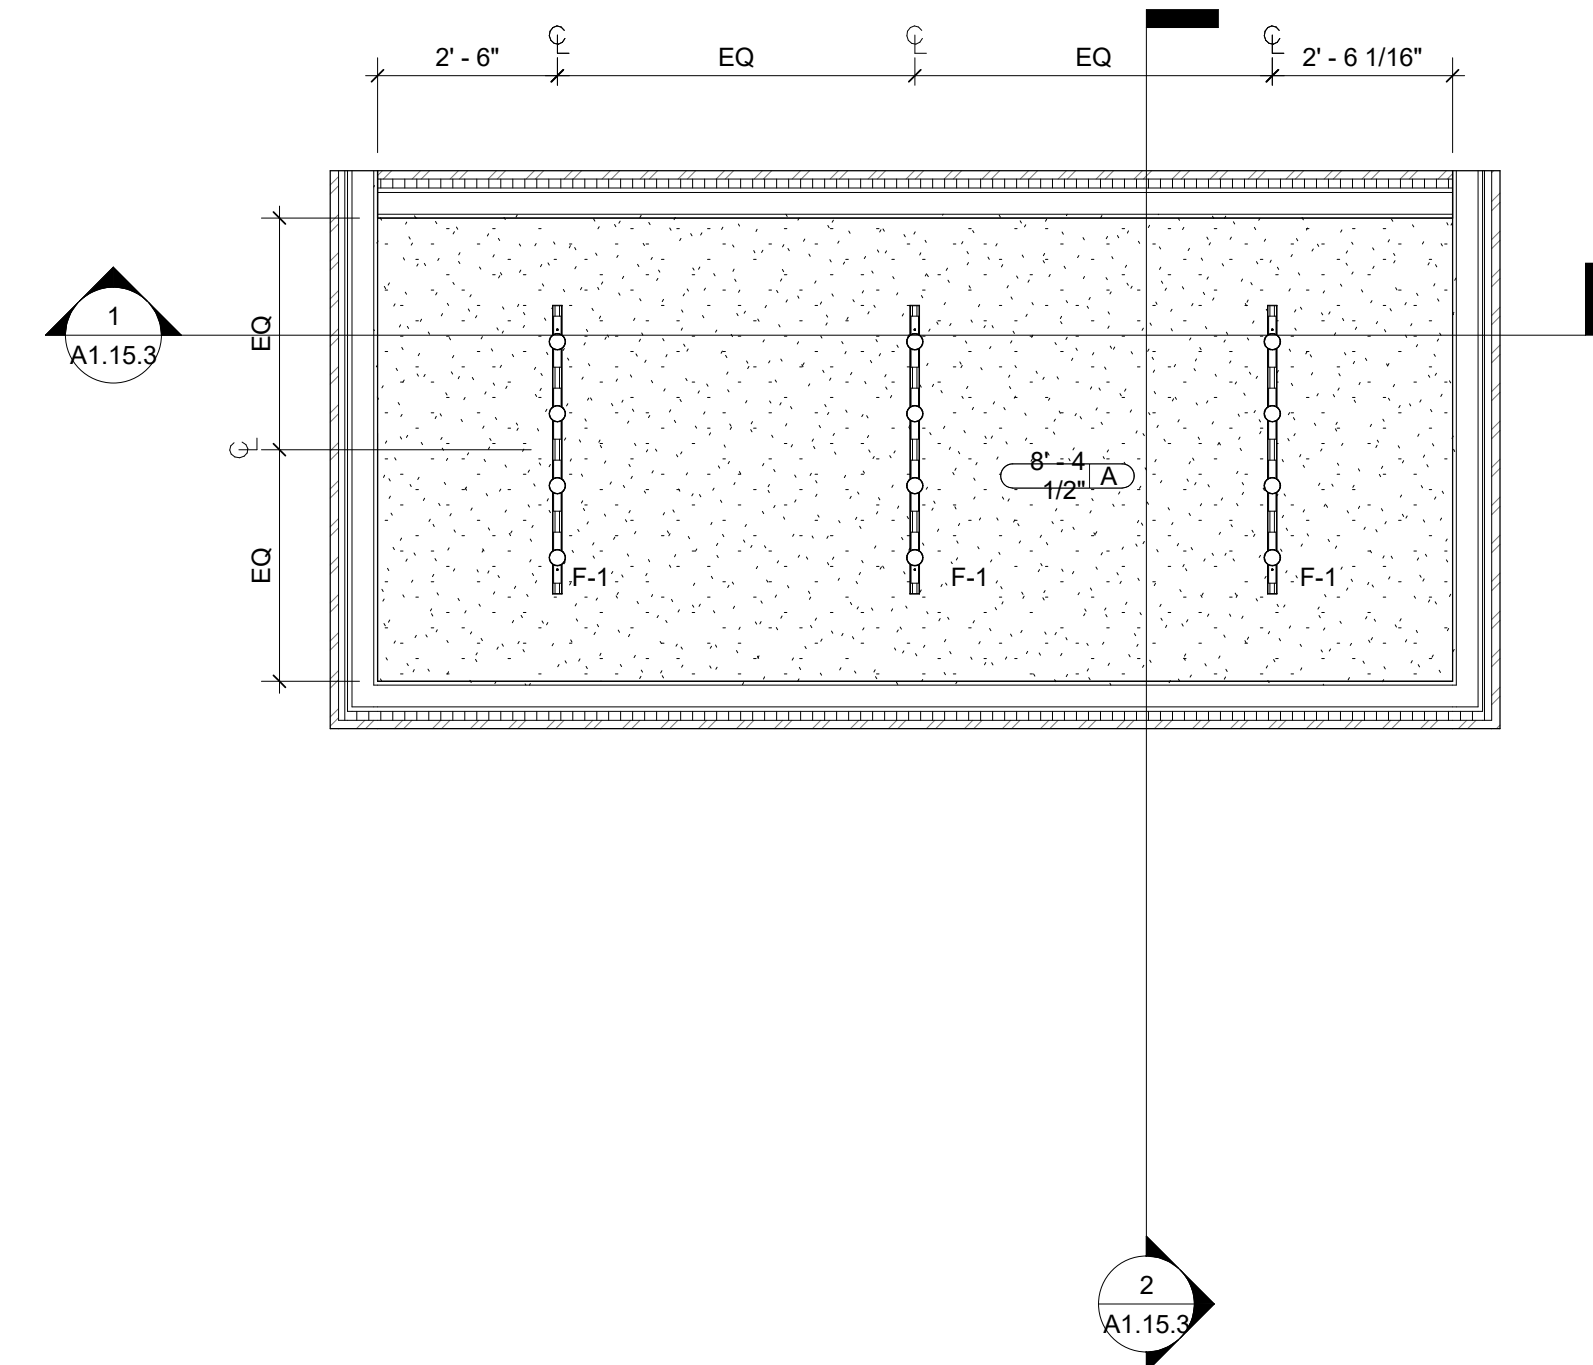


2 REFLECTED CEILING PLAN - 1.5D ONLY 3/8" = 1'-0"

CEILING SYMBOL	DESCRIPTION	REMARKS
	CEILING TYPE A: NEW GYPSUM CEILING	PAINTED PT-1, U.O.N.
	TRACK LIGHT FIXTURE SPEC: WAC LIGHTING TK-104 TRACK KIT	
	CEILING TYPE	
	CEILING HEIGHT FROM A.F.F.	

5 RCP NOTES 1/8" = 1'-0"

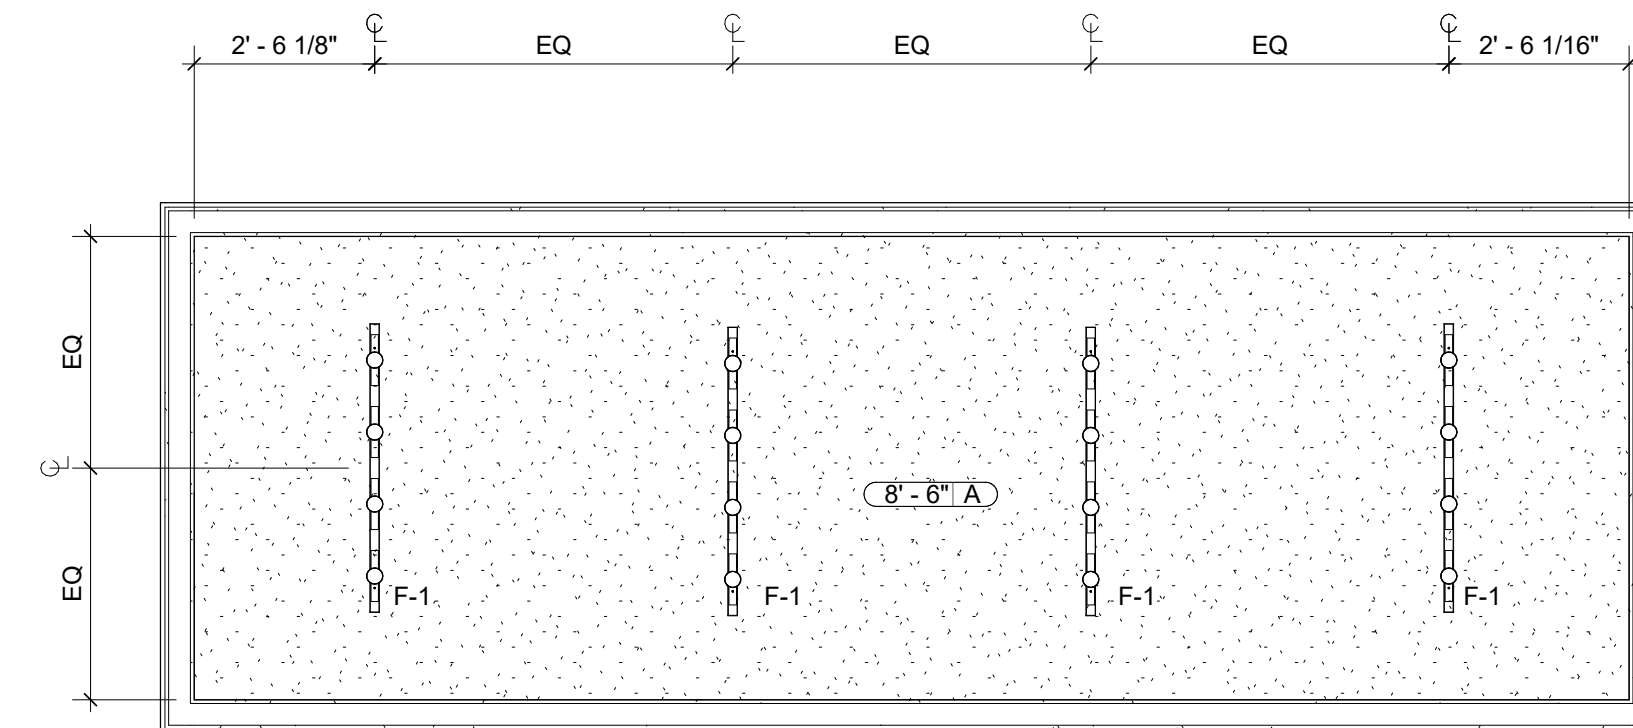

3 REFLECTED CEILING PLAN - 2D 3/8" = 1'-0"

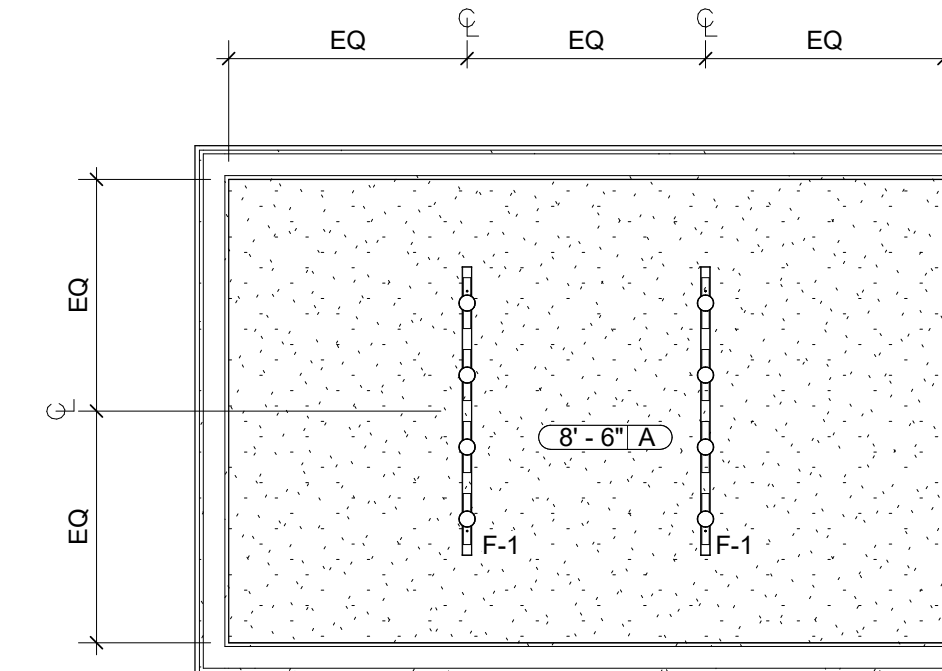

1 REFLECTED CEILING PLAN - 1D ONLY 3/8" = 1'-0"

This drawing is the property of Associated Space Design, Inc. and is not to be reproduced or copied in whole or part. It is not to be used on any other project and is to be returned upon request. Scales as stated herein are for reference only as normal reproduction processes may alter the accuracy of original drawings. Associated Space Design, Inc. 2015

NO.	DATE	REMARKS

NO. DATE REMARKS

REVISIONS:

DRAWING TITLE:
REFLECTED CEILING PLAN

PROJECT NO.: ISSUE DATE:

DRAWN BY: CHECKED BY:

Author Checker

SHEET NUMBER:

A2.00